



This drawing is a copyright & the property of MAYA DESIGN GOA & is not to be copied or handed over to a third party or for use for any other purpose, other than for which it is handed.

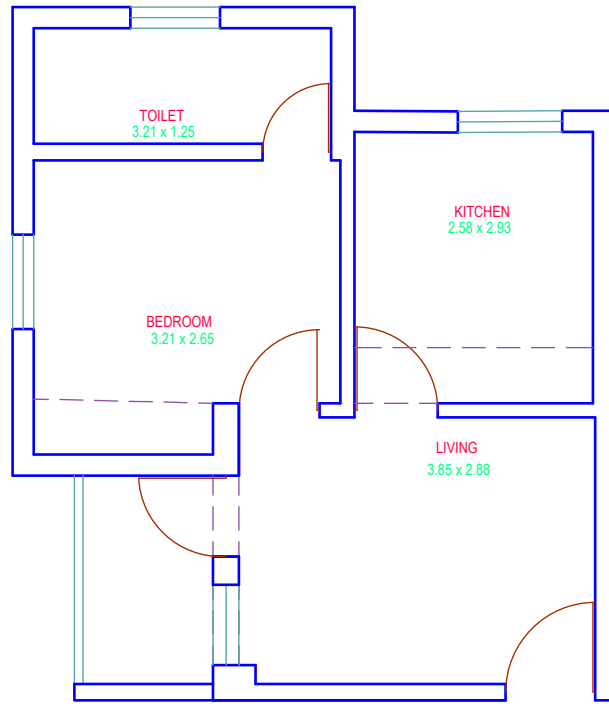

PROPOSED CIVIL CHANGE PLAN

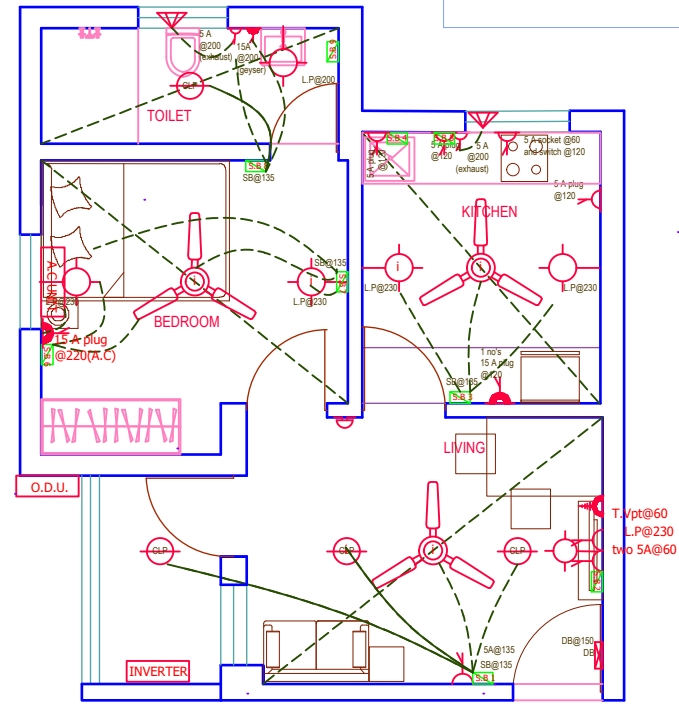

PROPOSED ELECTRICAL PLAN

Title: Proposed civil change plan and proposed electrical layout	Date : 22-09-2016	MAYA DESIGN GOA Ar.Yatin Jain 905, PUNDALIK NAGAR, ALTO PORVORIM, BARDEZ, GOA-403521 Tel: (0832) 2411145 Mb: 08975380333 email:yatin@mayadesigngoa.co.in
Client : Nabard, Goa Regional office	Drg No : EP/05/003	
Project : Renovation of Staff Quarters of Goa RO at Milroc Ribandar Retreat	Scale : NTS	
	Drn By : Ar.Yatin Jain	