



This drawing is a copyright & the property of MAYA DESIGN GOA & is not to be copied or handed over to a third party or for use for any other purpose, other than for which it is handed.

TYPE - 2
1 BHK 60 sq.m

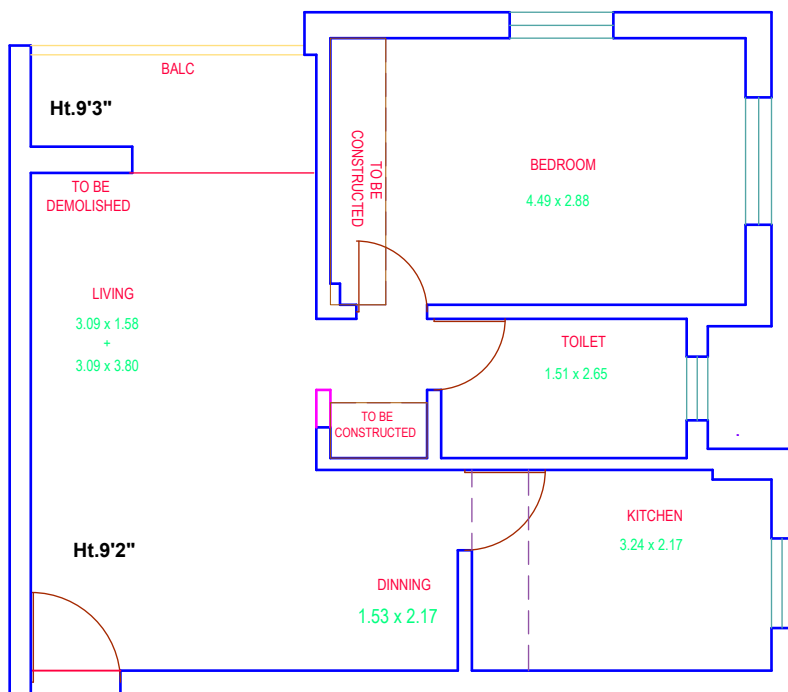

PROPOSED CIVIL CHANGE PLAN

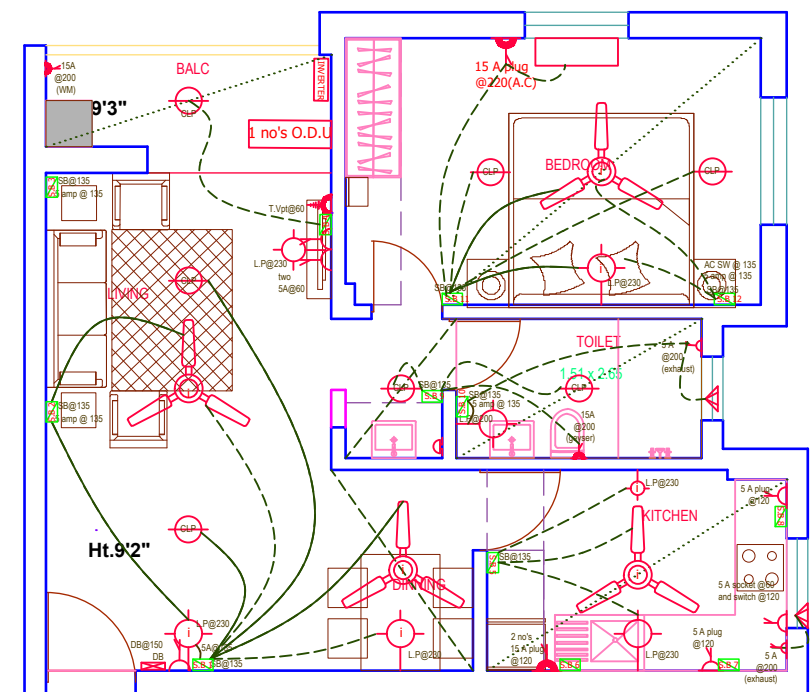

PROPOSED ELECTRICAL PLAN

| | | |
|---|---------------------------------------|--|
| Title: Proposed civil change plan and proposed electrical layout | Date : 22-09-2016 | MAYA DESIGN GOA Ar.Yatin Jain 905, PUNDALIK NAGAR, ALTO PORVORIM, BARDEZ, GOA-403521 Tel: (0832) 2411145 Mb: 08975380333 email:yatin@mayadesigngoa.co.in |
| Client : Nabard, Goa Regional office | Drg No : EP/05/002 | |
| Project : Renovation of Staff Quarters of Goa RO at Milroc Ribandar Retreat | Scale : NTS Drn By : Ar.Yatin Jain | |