



This drawing is a copyright & the property of MAYA DESIGN GOA & is not to be copied or handed over to a third party or for use for any other purpose, other than for which it is handed.

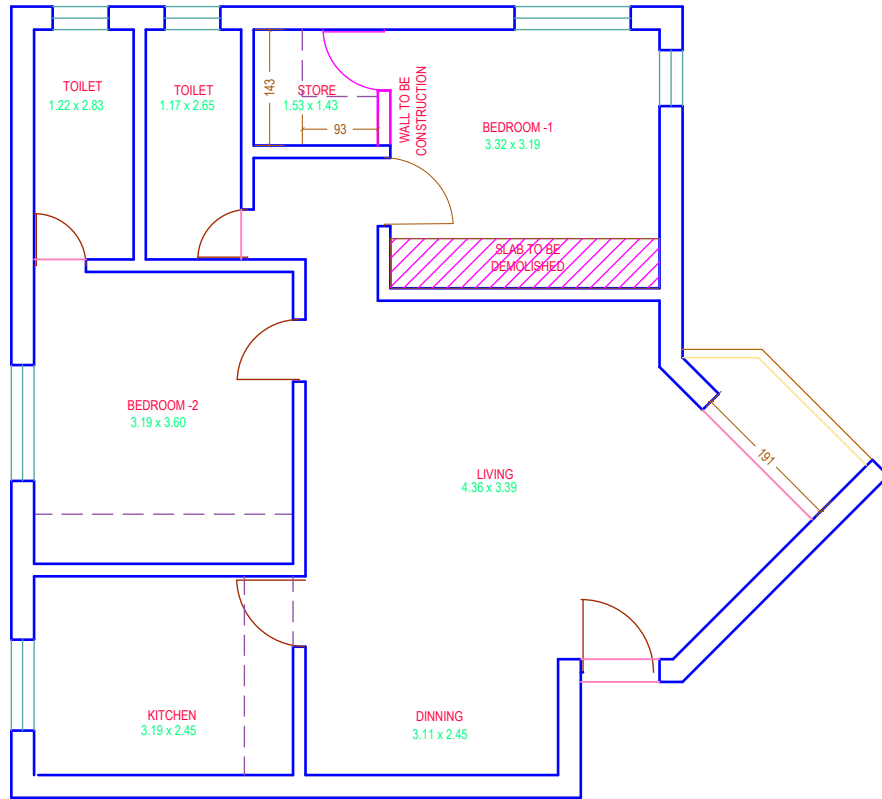

PROPOSED CIVIL CHANGE PLAN

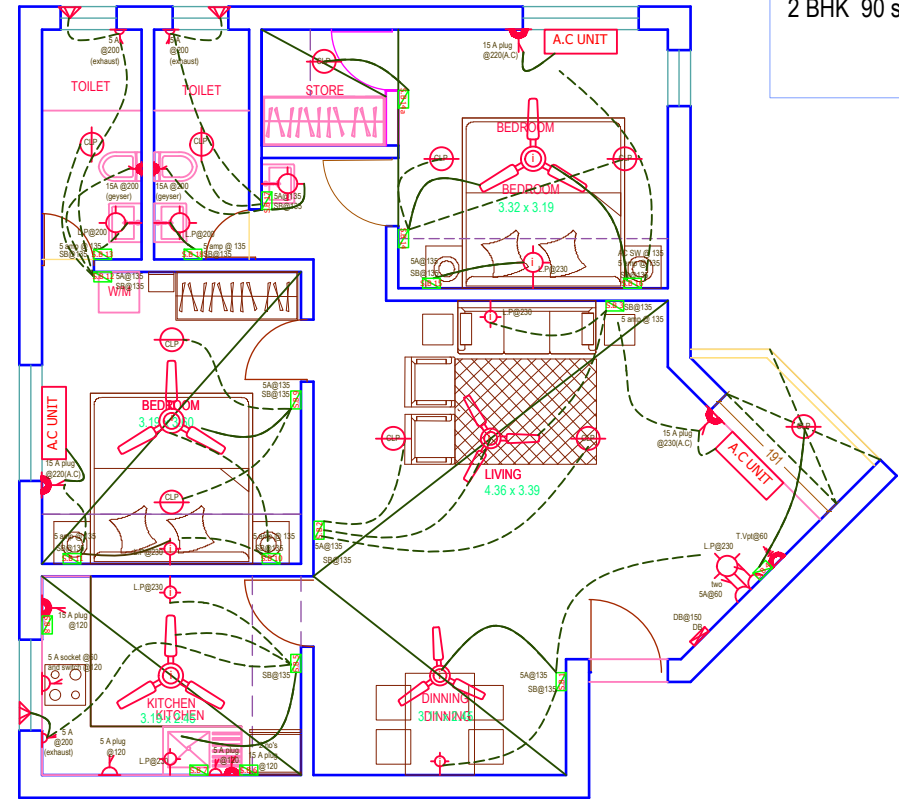

PROPOSED ELECTRICAL PLAN

TYPE - 1
2 BHK 90 sq.m

Title: Proposed civil change plan and proposed electrical layout

Client : Nabard, Goa Regional office

Project : Renovation of Staff Quarters of Goa RO at Milroc Ribandar Retreat

Date : 22-09-2016

Drg No : EP/05/001

Scale : NTS

Drn By : Ar.Yatin Jain

MAYA DESIGN GOA
Ar.Yatin Jain
905, PUNDALIK NAGAR,
ALTO PORVORIM,
BARDEZ,
GOA-403521
Tel: (0832) 2411145
Mb: 08975380333
email:yatin@mayadesigngoa.co.in